



CORRIGENDUM 4

Tender ID: 2025_IITS_846154_1, Dt. 25.01.2025

Tender Reference No.: IIITS_NIT_029_2025

Name of the Work: Civil, PHE, Fire Fighting, Electrical and associated External Development Works for the Construction of Academic Block (AB2) with B+G+2 floors as RCC framed structure and Boys Hostel Block (BH5) with G+10 floors as shear wall structure at IIIT Sri City Campus.

Corrigendum Details: Minutes of Pre-bid meeting held at IIIT Sri City.

Pre-bid Meeting Schedule: 03.02.2025 at 11:00 Hrs. (Hybrid Mode)

The following tender drawings shall be referred as part of the pre-bid meeting clarifications and revised list of tender drawings is enclosed.

S. No.	Drawing Title	Drawing No.	Rev No.
1	Overall Single Line Diagram	IIITS / ABNE / TD / EL- 031	R2
2	Expansion joint -Typical Details	IIITS / BH5 / TD / AR-552	R0
3	Water Supply Schematic Diagram	IIITS / BH5 / TD / PL-300	R0
4	Plumbing - Typical Details	IIITS / BH5 / TD / PL-400	R0
5	Fire Fighting Schematic Layout	IIITS / BH5 / TD / FF-300	R0
6	Overall Single line Diagram	IIITS / BH5 / TD / EL-051	R1
7	IIITS Master Plan	IIITS / ED / TD / AR-001	R0

Note:


- These minutes of pre-bid meeting shall form the part of bid document/Agreement.
- Rest of the terms and conditions and specifications of the bid document shall continue to remain same.
- The above amendments/ clarifications are issued for the information for all the intending bidders.
- The submission of bid by the firm shall be construed to be in conformity to the bid document and amendments/ clarifications given above.

NIT NO.: IIITS/NIT/AB2&BH5/2025/029, Dt. 25/01/2025			
VOLUME VI			
LIST OF TENDER DRAWINGS			
Sl.	Drawing Title	Drawing No.	Rev No.
Academic Block NE			
Architectural Tender Drawings			
1	Basement Floor Plan / Lower Ground Floor Plan	IIITS / ABNE / TD / AR-101	R2
2	Ground Floor Plan	IIITS / ABNE / TD / AR-102	R2
3	First Floor Plan	IIITS / ABNE / TD / AR-103	R2
4	Second Floor Plan	IIITS / ABNE / TD / AR-104	R2
5	Terrace Level Plan	IIITS / ABNE / TD / AR-105	R2
6	Schedule of Finishes	IIITS / ABNE / TD / AR-111	R2
7	Elevations (Sheet 1)	IIITS / ABNE / TD / AR-201	R1
8	Elevations (Sheet 2)	IIITS / ABNE / TD / AR-202	R1
9	Sections (Sheet 1)	IIITS / ABNE / TD / AR-301	R1
10	Sections (Sheet 2)	IIITS / ABNE / TD / AR-302	R1
11	Typical Glazing & Window Detail	IIITS / ABNE / TD / AR-401	R0
12	Staircase 01 & 03 Details	IIITS / ABNE / TD / AR-501	R1
13	Staircase 02 Details	IIITS / ABNE / TD / AR-502	R2
14	Typical Details	IIITS / ABNE / TD / AR-551	R0
15	Expansion joint -Typical Details	IIITS / ABNE / TD / AR-552	R0
Connecting Corridor Architectural Tender Drawings			
16	Ground & First Floor Plans	IIITS / ABCC / TD / AR-101	R0
17	Terrace Level Plan & Front Elevation	IIITS / ABCC / TD / AR-201	R0
18	Rear Elevation & Sections	IIITS / ABCC / TD / AR-301	R0
Structural Tender Drawings			
19	Numeration Layout of Raft Slab	IIITS / ABNE / TD / ST-01	R0
20	Layout of Lower Ground Floor Roof Slabs & Beams	IIITS / ABNE / TD / ST-02	R0
21	Layout of Ground Floor Roof Slabs & Beams	IIITS / ABNE / TD / ST-03	R0
22	Layout of First Floor Roof Slabs & Beams	IIITS / ABNE / TD / ST-04	R0
23	Layout of Terrace Floor Slabs and Beams	IIITS / ABNE / TD / ST-05	R0
Plumbing Tender Drawings			
24	Plumbing Layout - Site Plan	IIITS / ABNE / TD / PL-001	R0
25	Plumbing Layout - Schematic Diagram	IIITS / ABNE / TD / PL-100	R1
26	Plumbing Layout - Basement Plan	IIITS / ABNE / TD / PL-101	R1
27	Plumbing Layout - Basement Ceiling Plan	IIITS / ABNE / TD / PL-102	R1
28	Plumbing Layout - Ground Floor Plan	IIITS / ABNE / TD / PL-103	R0
29	Plumbing Layout - First Floor Plan	IIITS / ABNE / TD / PL-104	R0
30	Plumbing Layout - Second Floor Plan	IIITS / ABNE / TD / PL-105	R0
31	Plumbing Layout - Terrace Level Plan	IIITS / ABNE / TD / PL-106	R0
32	Drainage & Water Supply Layouts - Typical Toilets	IIITS / ABNE / TD / PL-200	R0
33	Drainage & Water Supply Layout - Basement Toilets	IIITS / ABNE / TD / PL-201	R1

Sl.	Drawing Title	Drawing No.	Rev No.
Firefighting Drawings			
34	Firefighting Systems - Schematic Diagram	IIITS / ABNE / TD / FF-100	R0
35	Firefighting Layout-Basement Floor Plan	IIITS / ABNE / TD / FF-101	R1
36	Firefighting Layout-Ground Floor Plan	IIITS / ABNE / TD / FF-102	R2
37	Firefighting Layout-First Floor Plan	IIITS / ABNE / TD / FF-103	R1
38	Firefighting Layout-Second Floor Plan	IIITS / ABNE / TD / FF-104	R1
39	Firefighting Layout-Terrace Floor Plan	IIITS / ABNE / TD / FF-105	R1
40	Fire Alarm System - Single Line Diagram	IIITS / ABNE / TD / FF-200	R1
Electrical Tender Drawings			
41	Equipment & Cable Routing Layout - Basement Floor	IIITS / ABNE / TD / EL- 011	R1
42	Equipment & Cable Routing Layout - Ground Floor	IIITS / ABNE / TD / EL- 012	R1
43	Equipment & Cable Routing Layout - First Floor	IIITS / ABNE / TD / EL- 013	R0
44	Equipment & Cable Routing Layout - Second Floor	IIITS / ABNE / TD / EL- 014	R0
45	Equipment & Cable Routing Layout - Terrace Floor	IIITS / ABNE / TD / EL- 015	R0
46	Electrical Layout & Details - Typical 60-Seater Classroom	IIITS / ABNE / TD / EL- 019A	R0
47	Electrical Layout & Details - Typical 80-Seater Classroom	IIITS / ABNE / TD / EL- 019B	R0
48	Electrical Layout & Details - Typical 120-Seater Lecture Hall	IIITS / ABNE / TD / EL- 019C	R1
49	Electrical Layout & Details- 484-Seater Auditorium	IIITS / ABNE / TD / EL- 019D	R0
50	Lighting Layout - Basement Floor	IIITS / ABNE / TD / EL- 020	R0
51	Small Power Layout - Basement Floor	IIITS / ABNE / TD / EL- 021	R0
52	Lighting Layout - Ground Floor	IIITS / ABNE / TD / EL- 022	R0
53	Small Power Layout - Ground Floor	IIITS / ABNE / TD / EL- 023	R0
54	Lighting Layout - First Floor	IIITS / ABNE / TD / EL- 024	R0
55	Small Power Layout - First Floor	IIITS / ABNE / TD / EL- 025	R0
56	Lighting Layout - Second Floor	IIITS / ABNE / TD / EL- 026	R0
57	Small Power Layout - Second Floor	IIITS / ABNE / TD / EL- 027	R0
58	Lighting and Small Power Layout Terrace Floor	IIITS / ABNE / TD / EL- 028	R0
59	Schematic Diagram of Data & CCTV Systems	IIITS / ABNE / TD / EL- 030	R0
60	Overall Single Line Diagram (Corrigendum 4)	IIITS / ABNE / TD / EL- 031	R2
61	LV Layout - Basement Floor	IIITS / ABNE / TD / EL- 037	R0
62	LV Layout - Ground Floor	IIITS / ABNE / TD / EL- 038	R0
63	LV Layout - First Floor	IIITS / ABNE / TD / EL- 039	R0
64	LV Layout - Second Floor	IIITS / ABNE / TD / EL- 040	R0
65	Structural Earthing Layout - Basement Floor	IIITS / ABNE / TD / EL- 052A	R0
66	Structural Earthing Layout - Ground Floor	IIITS / ABNE / TD / EL- 052B	R0
67	Structural Earthing Layout - First Floor	IIITS / ABNE / TD / EL- 052C	R0
68	Structural Earthing Layout - Second Floor	IIITS / ABNE / TD / EL- 052D	R0
69	Structural Earthing Layout - Terrace Floor	IIITS / ABNE / TD / EL- 052E	R0

Sl.	Drawing Title	Drawing No.	Rev No.
Boys Hostel 5			
Architectural Tender Drawings			
1	Ground Floor Plan	IIITS / BH5 / TD / AR-101	R2
2	First Floor Plan	IIITS / BH5 / TD / AR-102	R2
3	Second Floor Plan	IIITS / BH5 / TD / AR-103	R2
4	Third, Fifth & Ninth Floors (Typical Floor Plan A)	IIITS / BH5 / TD / AR-104	R2
5	Fourth & Sixth Floors (Typical Floor Plan B)	IIITS / BH5 / TD / AR-105	R2
6	Seventh Floor Plan	IIITS / BH5 / TD / AR-106	R2
7	Eighth & Tenth Floors (Typical Floor Plan C)	IIITS / BH5 / TD / AR-107	R2
8	Ninth Floor Plan	IIITS / BH5 / TD / AR-108	R2
9	Terrace Level Plan	IIITS / BH5 / TD / AR-109	R2
10	Mumty & OHT Roof level Plan	IIITS / BH5 / TD / AR-110	R0
11	Schedule of Finishes	IIITS / BH5 / TD / AR-111	R1
12	Elevation E1	IIITS / BH5 / TD / AR-201	R2
13	Elevation E2	IIITS / BH5 / TD / AR-202	R2
14	Elevation E3	IIITS / BH5 / TD / AR-203	R2
15	Elevation E4	IIITS / BH5 / TD / AR-204	R2
16	Sections (Sheet 1)	IIITS / BH5 / TD / AR-301	R2
17	Sections (Sheet 2)	IIITS / BH5 / TD / AR-302	R2
18	Sections (Sheet 3)	IIITS / BH5 / TD / AR-303	R2
19	Staircase 1 Details	IIITS / BH5 / TD / AR-501	R1
20	Staircase 2 Details	IIITS / BH5 / TD / AR-502	R2
21	Staircase 3 Details	IIITS / BH5 / TD / AR-503	R2
22	Typical Hostel Room Details	IIITS / BH5 / TD / AR-521	R0
23	Typical Details	IIITS / BH5 / TD / AR-551	R0
24	Expansion joint -Typical Details (Corrigendum 4)	IIITS / BH5 / TD / AR-552	R0
Structural Tender Drawings			
25	Numeration Layout of Raft Slab	IIITS / BH5 / TD / ST-01	R1
26	Layout of RC Walls (upto Ground Floor)	IIITS / BH5 / TD / ST-02	R1
27	Layout of RC Walls (From Ground Floor to top)	IIITS / BH5 / TD / ST-03	R1
28	Layout of Grid Beam & Non Structural Grade Slab in Ground Floor	IIITS / BH5 / TD / ST-04	R1
29	Layout of First Floor Slabs & Beams	IIITS / BH5 / TD / ST-05	R1
30	Layout of Second Floor Slabs & Beams	IIITS / BH5 / TD / ST-06	R1
31	Layout of Third & Fifth Floor Slabs & Beams	IIITS / BH5 / TD / ST-07	R1
32	Layout of 4th & 6th Floors Slabs & Beams	IIITS / BH5 / TD / ST-08	R1
33	Layout of Seventh Floor Slabs & Beams	IIITS / BH5 / TD / ST-09	R1
34	Layout of 8th & 10th Floor Slabs & Beams	IIITS / BH5 / TD / ST-10	R1
35	Layout of 9th Floor Slabs & Beams	IIITS / BH5 / TD / ST-11	R1
36	Layout of Terrace Floor Slabs & Beams	IIITS / BH5 / TD / ST-12	R1







Sl.	Drawing Title	Drawing No.	Rev No.
Plumbing & Firefighting Tender Drawings			
37	Plumbing Layout - Site Plan	IIITS / BH5 / TD / PLFF-001	R0
38	Plumbing & Firefighting Layout - Ground Floor Plan	IIITS / BH5 / TD / PLFF-101	R2
39	Plumbing & Firefighting Layout - First Floor Plan	IIITS / BH5 / TD / PLFF-102	R1
40	Plumbing & Firefighting Layout - Second Floor Plan	IIITS / BH5 / TD / PLFF-103	R1
41	Plumbing & Firefighting Layout - Third & Fifth Floor Typical Plans	IIITS / BH5 / TD / PLFF-104	R1
42	Plumbing & Firefighting Layout - Fourth & Sixth Floor Typical Plans	IIITS / BH5 / TD / PLFF-105	R1
43	Plumbing & Firefighting Layout - Seventh Floor Plan	IIITS / BH5 / TD / PLFF-106	R1
44	Plumbing & Firefighting Layout - Eighth & Tenth Floor Typical Plans	IIITS / BH5 / TD / PLFF-107	R1
45	Plumbing & Firefighting Layout - Ninth Floor Plan	IIITS / BH5 / TD / PLFF-108	R1
46	Plumbing & Firefighting Layout - Terrace Level Plan	IIITS / BH5 / TD / PLFF-109	R1
47	Plumbing Details - Typical Toilet, Wash & Dry Areas	IIITS / BH5 / TD / PL-200	R0
48	Water Supply Schematic Diagram (Corrigendum 4)	IIITS / BH5 / TD / PL-300	R0
49	Plumbing - Typical Details (Corrigendum 4)	IIITS / BH5 / TD / PL-400	R0
50	Fire Alarm System - Single Line Diagram	IIITS / BH5 / TD / FF-200	R1
51	Fire Fighting Schematic Layout (Corrigendum 4)	IIITS / BH5 / TD / FF-300	R0
Electrical Tender Drawings			
52	Equipments & Cable Routing Layout - Ground Floor	IIITS / BH5 / TD / EL-011	R1
53	Equipments & Cable Routing Layout - Typical Floor	IIITS / BH5 / TD / EL-012	R1
54	Earthing & Schematic Layout - Ground Floor	IIITS / BH5 / TD / EL-014-1	R1
55	Earthing & Schematic Layout - First Floor	IIITS / BH5 / TD / EL-014-2	R0
56	Earthing & Schematic Layout - Terrace Floor	IIITS / BH5 / TD / EL-014-3	R0
57	Details & Legend - Electrical Systems	IIITS / BH5 / TD / EL-014-4	R0
58	Lighting & Small Power Layout - Typical Room	IIITS / BH5 / TD / EL-022	R0
59	Lighting Layout - Ground Floor	IIITS / BH5 / TD / EL-023	R1
60	Small Power Layout - Ground Floor	IIITS / BH5 / TD / EL-024	R1
61	Lighting Layout - Typical Floor	IIITS / BH5 / TD / EL-025	R1
62	Small Power Layout - Typical Floor	IIITS / BH5 / TD / EL-026	R1
63	Lighting & Small Power Layout - Terrace Floor	IIITS / BH5 / TD / EL-027	R1
64	LV Layout - Ground Floor	IIITS / BH5 / TD / EL-028	R0
65	LV Layout - Typical Floor (First to Tenth Floors)	IIITS / BH5 / TD / EL-029	R0
66	Schematic Diagram of Data & CCTV Systems	IIITS / BH5 / TD / EL-040	R0
67	Single line Diagram Ground Floor	IIITS / BH5 / TD / EL-041	R0
68	Single Line Diagram Typical Floor	IIITS / BH5 / TD / EL-042	R0
69	Overall Single line Diagram (Corrigendum 4)	IIITS / BH5 / TD / EL-051	R1
External Development Works			
70	IIITS Master Plan (Corrigendum 4)	IIITS / ED / TD / AR-001	R0
71	IIITS Master Plan - Site Barricade		
72	IIITS Master Plan - Asphalt Road Details		
73	IIITS Master Plan - Service Trench Details		

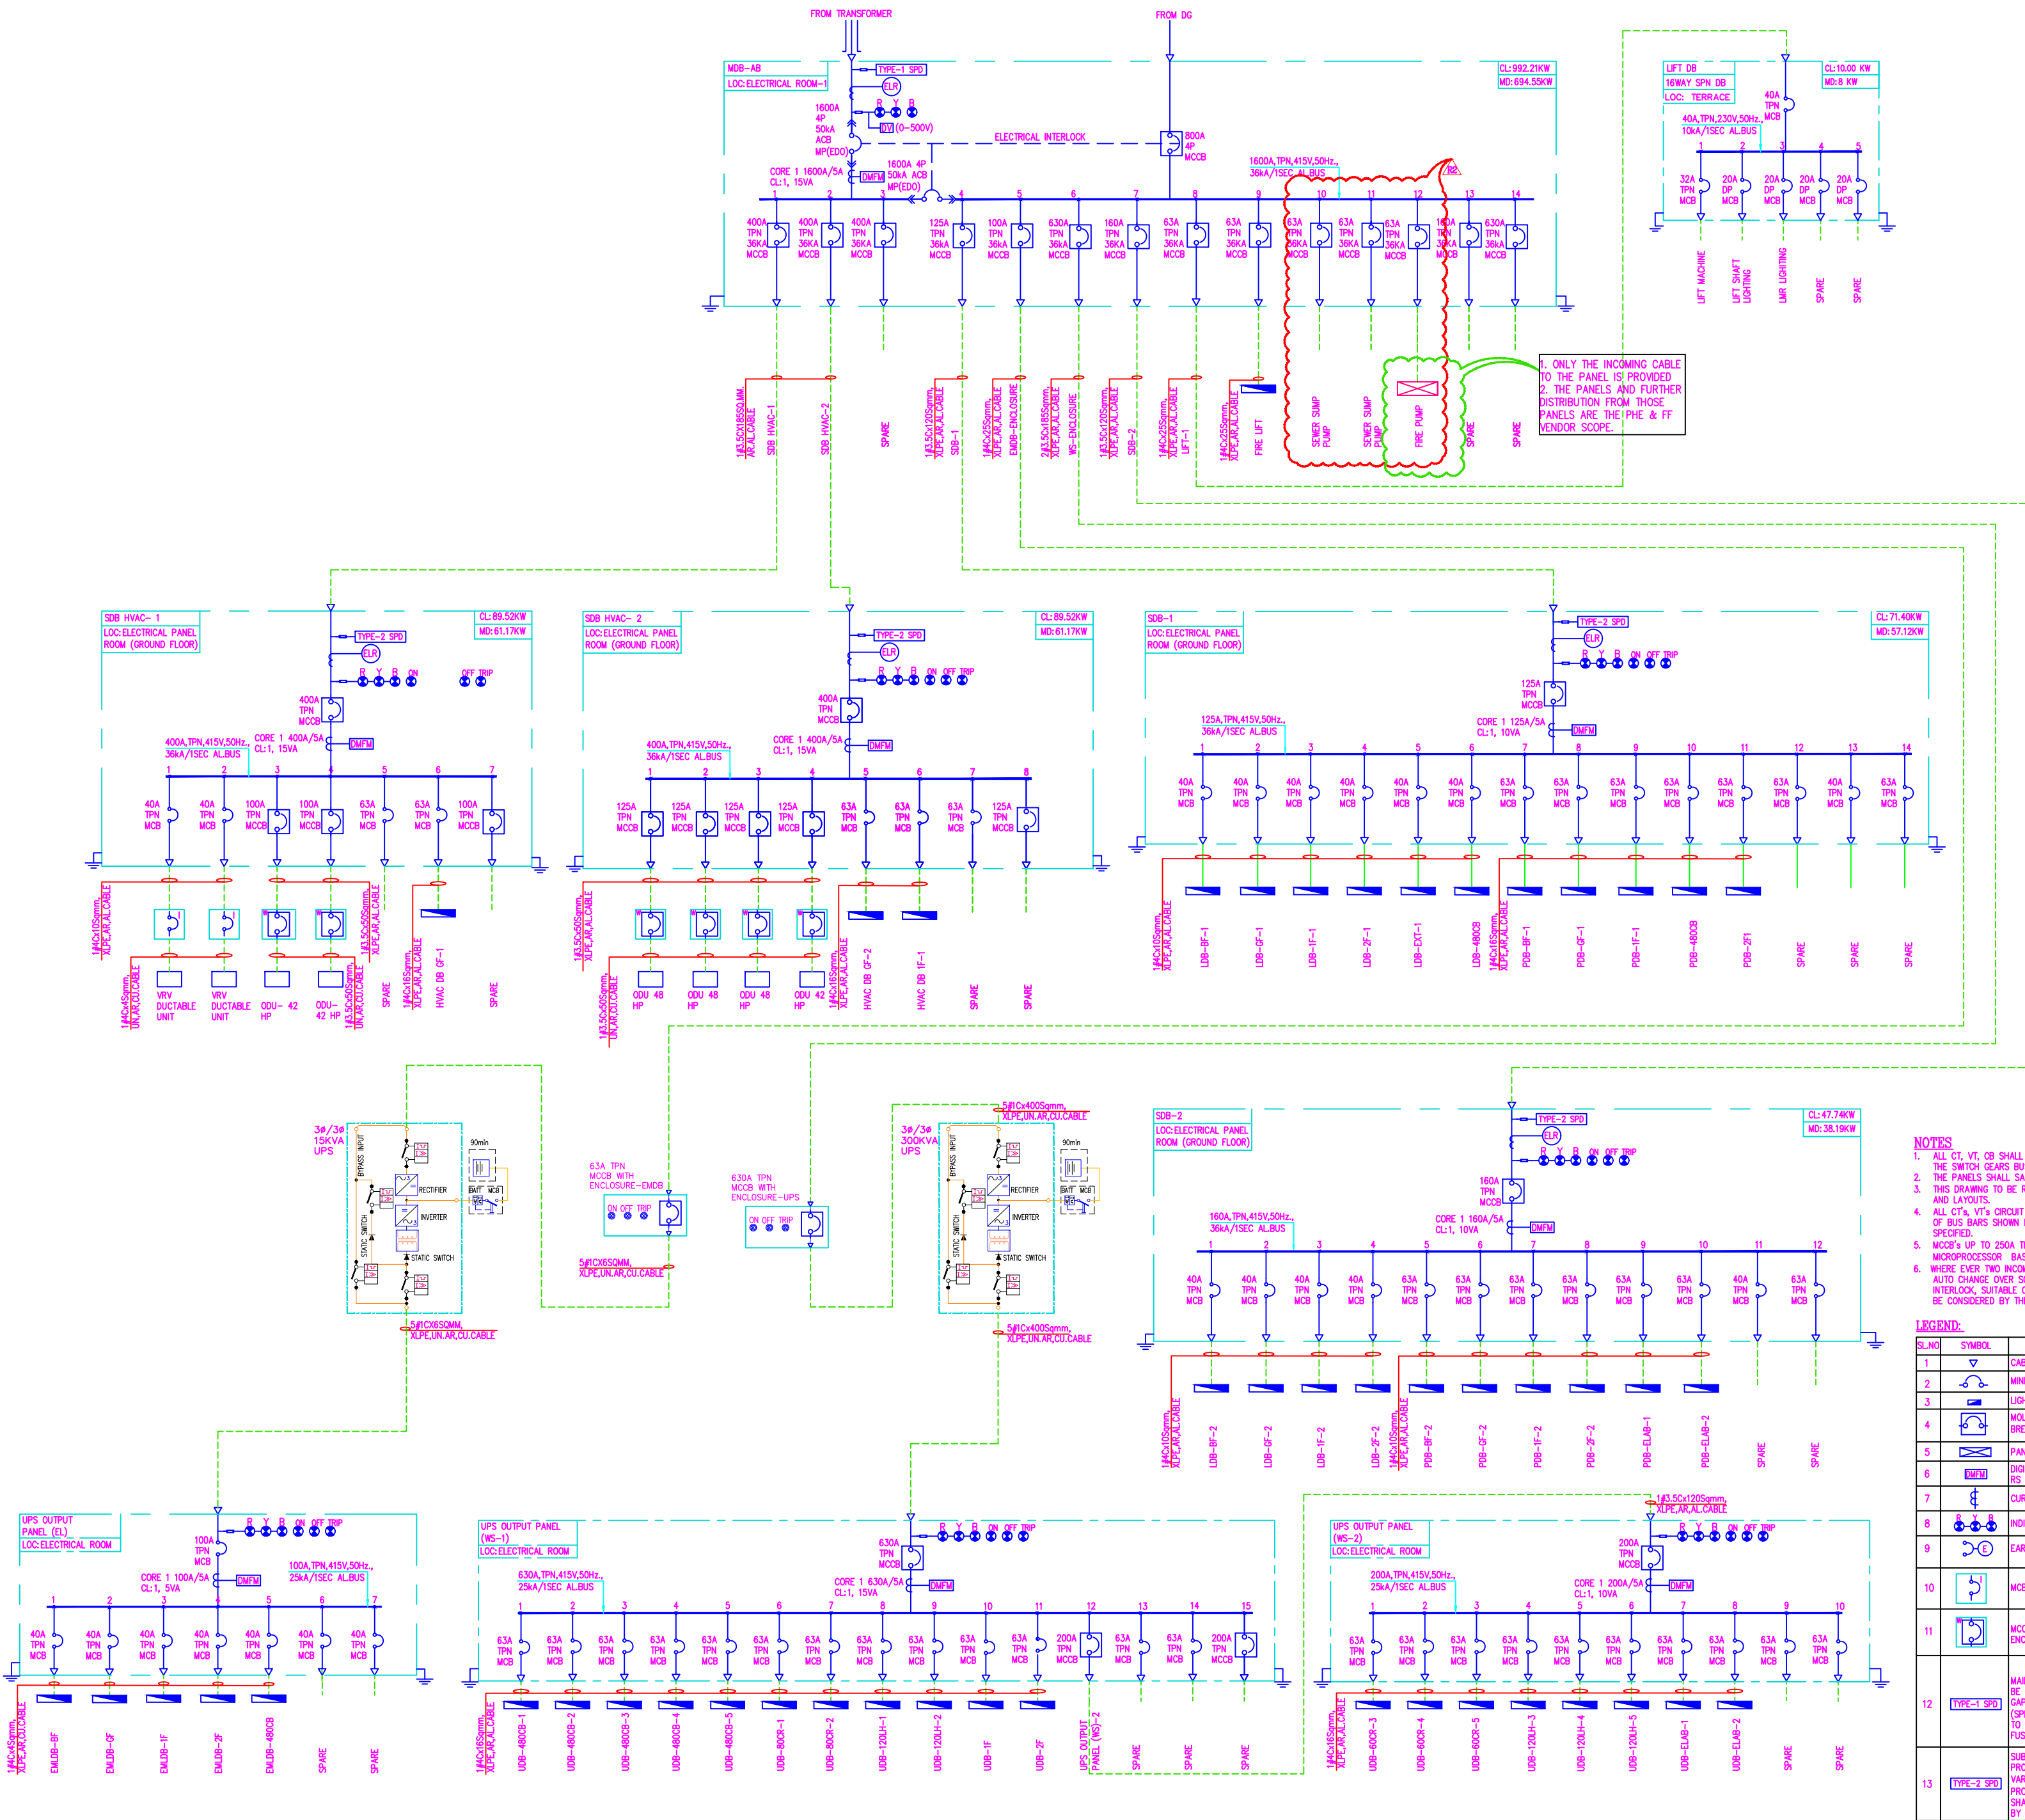

REVISIONS:		
SL.	DATE	DESCRIPTION
R1	25.11.2024	REVISED AS MARKED
R2	11.02.2025	REVISED AS MARKED
-	-	-
-	-	-
-	-	-
-	-	-
-	-	-
-	-	-
-	-	-

ELECTRICAL CONSULTANT	
SV Intense Engineering Infrastructure Pvt. Ltd.	
Vadachery, Chennai - 600042	
PLUMBING & FIRE-FIGHTING CONSULTANT	
Behara & Associates	
F-623A, Lado Sarai, Behind CNG Station, New Delhi	
HVAC CONSULTANT	
Abid Husain Consultants	
LG-182, Jeevan Prakash Apartment, 16A, Okhla, New Delhi	
STRUCTURAL CONSULTANT	
Jehovaking Engineering Consultants Pvt. Ltd.	
6th Cross Street, Lakshmi Nagar, Porur, Chennai - 600116	
PROJECT	
Infrastructure Development at IIIT Sri City	
Chittoor	
CLIENT	
Indian Institute of Information Technology	
Sri City, Chittoor	
Andhra Pradesh	
ARCHITECT	
Aadharshila Designs Pvt. Ltd.	
B-4/124, L. G. F., Safdarjung Enclave, New Delhi - 110029.	
Tel: +91 11 26104333 - 6, Fax: +91 11 26177678,	
E-mail: adp@gadp.in	
COPYRIGHT	
This drawing is the property of Aadharshila Designs Pvt. Ltd. It shall not be copied, used in any manner and handed over to any person or party without the prior permission of Aadharshila Designs Pvt. Ltd.	
DRAWING TITLE	
Over All Single Line Diagram	
Academic Block NE	
DATE	SCALE
24.10.2024	1:150 @ A1
DRAWING NO.	REV.
IIITS / ABNE / TD / EL-031	R2

DETAILED ELECTRICAL DRAWINGS (FOR TENDER)

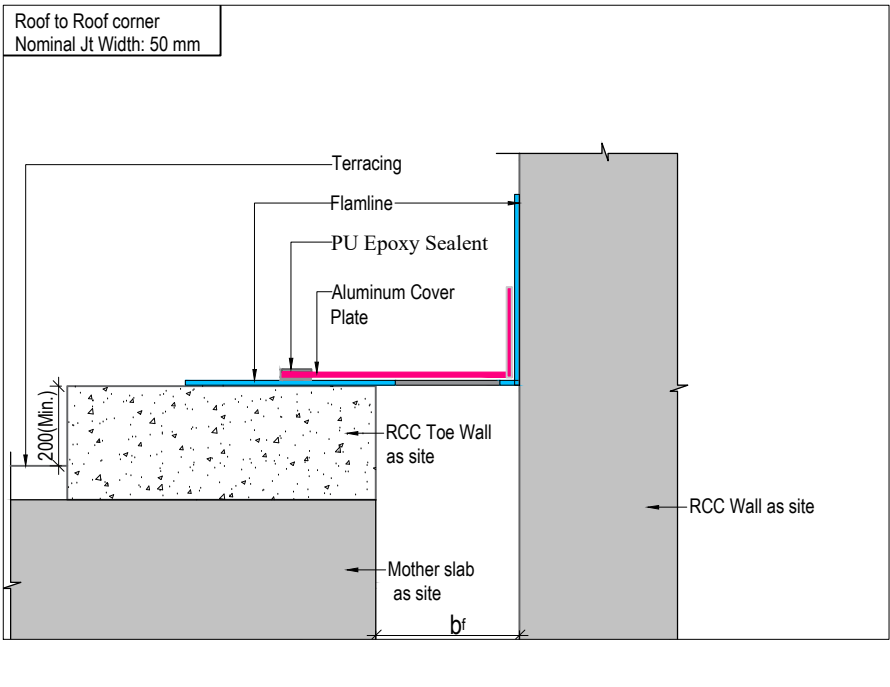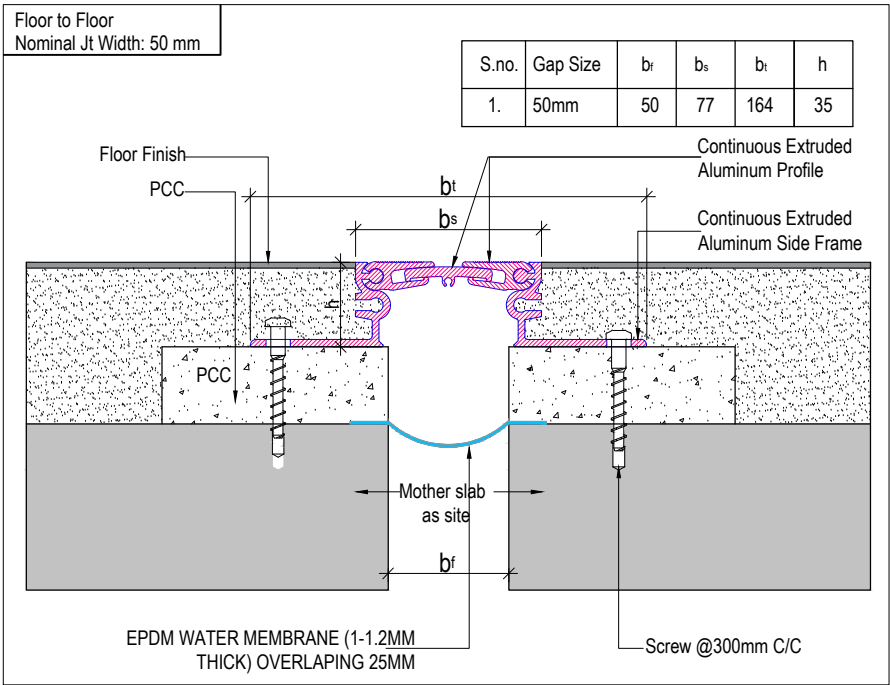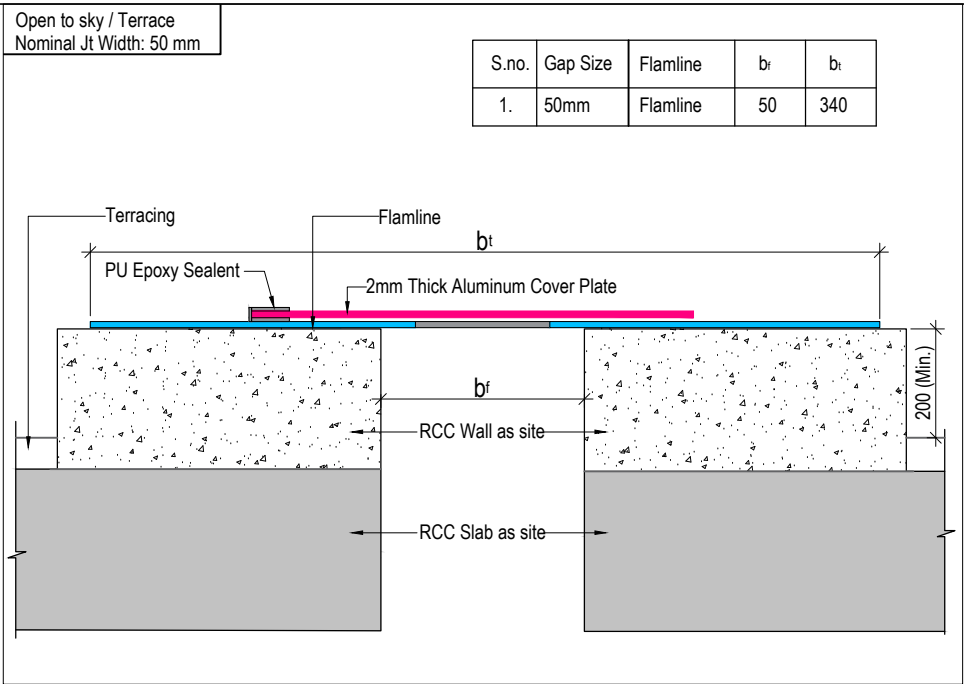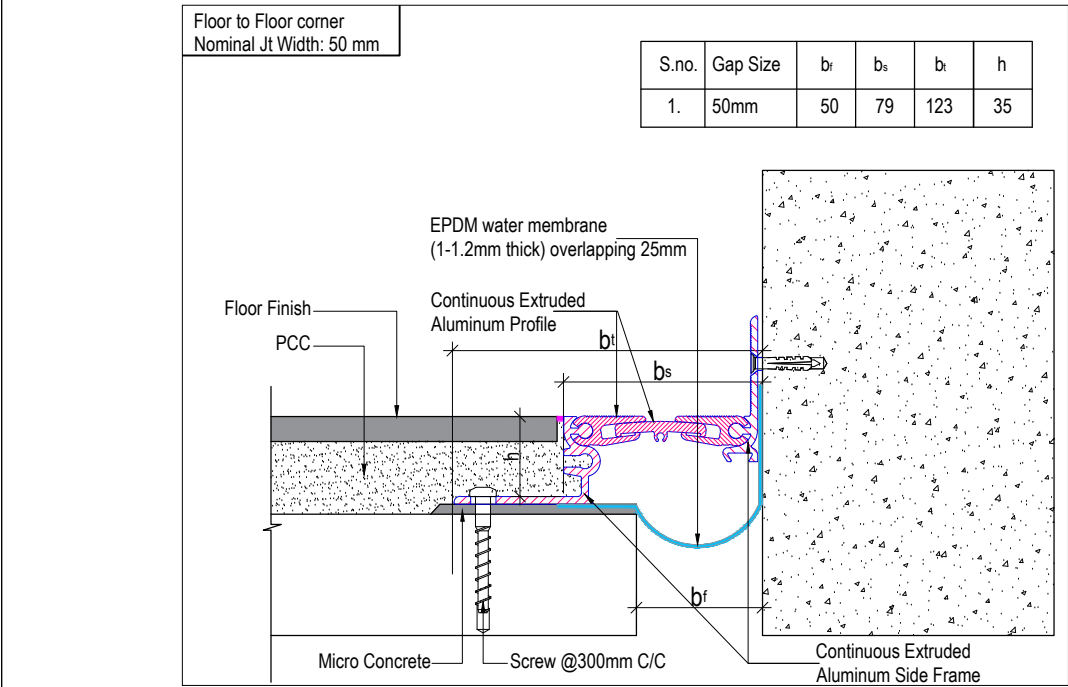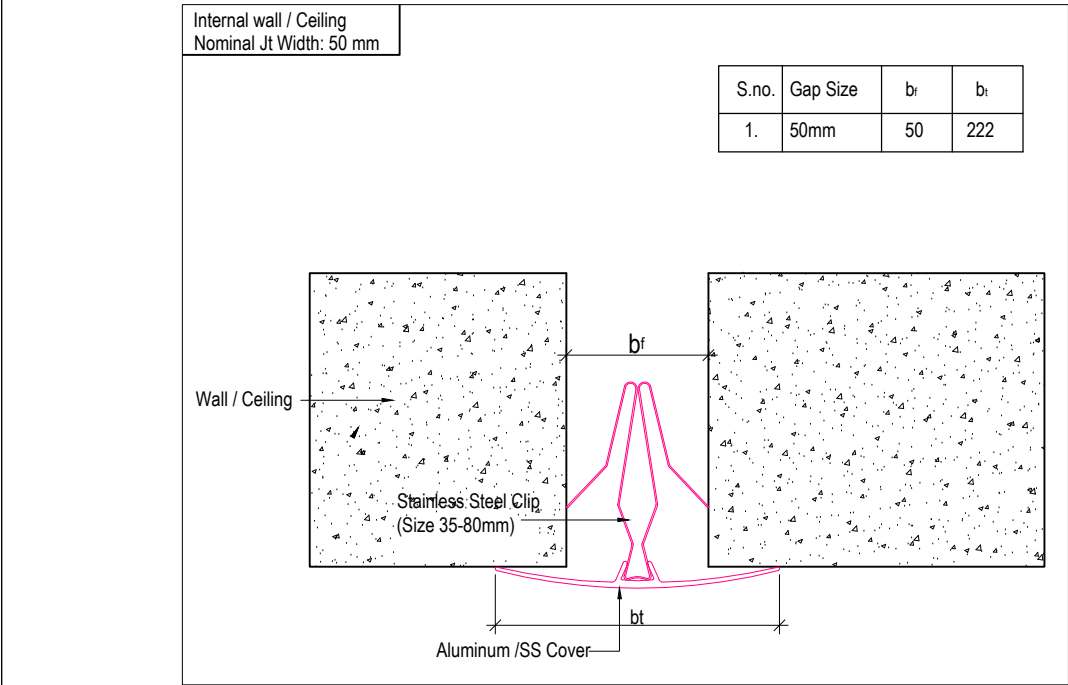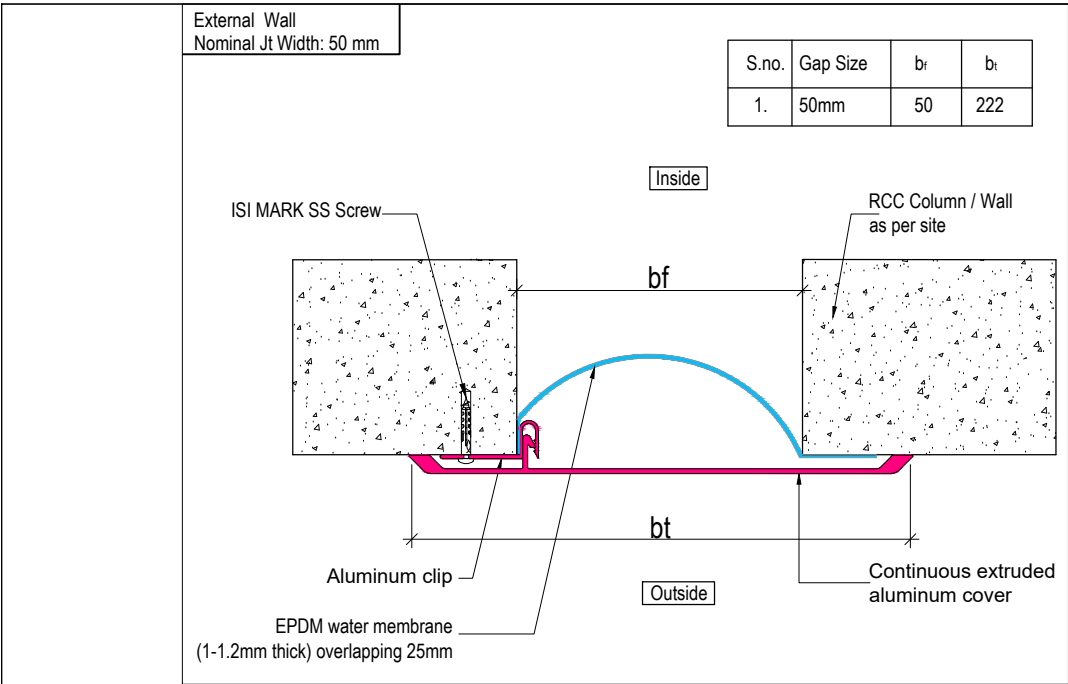

- NOTES:
1. All dimensions are in mm unless noted otherwise.
 2. The dimensions are to be read and not scaled off the drawing.
 3. Any discrepancy in the drawing shall be brought to the notice of the Architects.
 4. This drawing is to be read in conjunction with other relevant drawings & specifications given in the tender document.
 5. Only the latest revision of the drawings shall be considered valid for all purposes.

REVISIONS:		
SL.	DATE	DESCRIPTION
-	-	-
-	-	-
-	-	-
-	-	-
-	-	-
-	-	-
-	-	-

NOTE:-
THE CONTRACTOR HAS TO SUBMIT SHOP DRAWINGS. EXECUTION SHALL BE DONE AS PER THE SHOP DRAWINGS APPROVED BY THE ARCHITECT / ENGINEER IN CHARGE.

ELECTRICAL CONSULTANT
SV Intense Engineering Infrastructure Pvt. Ltd.
Velachery, Chennai - 600042

PLUMBING & FIRE-FIGHTING CONSULTANT
Behera & Associates
F-623A, Lado Sarai, Behind CNG Station, New Delhi

HVAC CONSULTANT
Abid Husain Consultants
LG-1&2, Jeevan Prakash Apartment, 16A, Okhla, New Delhi

STRUCTURAL CONSULTANT
Jehovaking Engineering Consultants Pvt. Ltd.
6th Cross Street, Lakshmi Nagar, Porur, Chennai - 600116

PROJECT
Infrastructure Development at IIIT Sri City
Chittoor


CLIENT
Indian Institute of Information Technology
Sri City, Chittoor
Andhra Pradesh

ARCHITECT
ADPL
Aadharshila Designs Pvt. Ltd.
B - 4/124, L. G. F., Safdarjung Enclave, New Delhi - 110029.
Tel : +91 11 26100433 - 6, Fax : +91 11 26177678,
E-mail : adpl@adpl.in

COPYRIGHT
This drawing is the property of Aadharshila Designs Pvt. Ltd. It shall not be copied, used in any manner and handed over to any person or party without the prior permission of Aadharshila Designs Pvt. Ltd.

DRAWING TITLE		
Expansion Joint Typical Details		
Boys Hostel 5		
DATE	SCALE	REV.
04.02.2025	1:10 @ A3	
DRAWING NO.		R0
IIITS / BH5 / TD / AR-552		

DETAILED ARCHITECTURAL DRAWINGS (FOR TENDER)

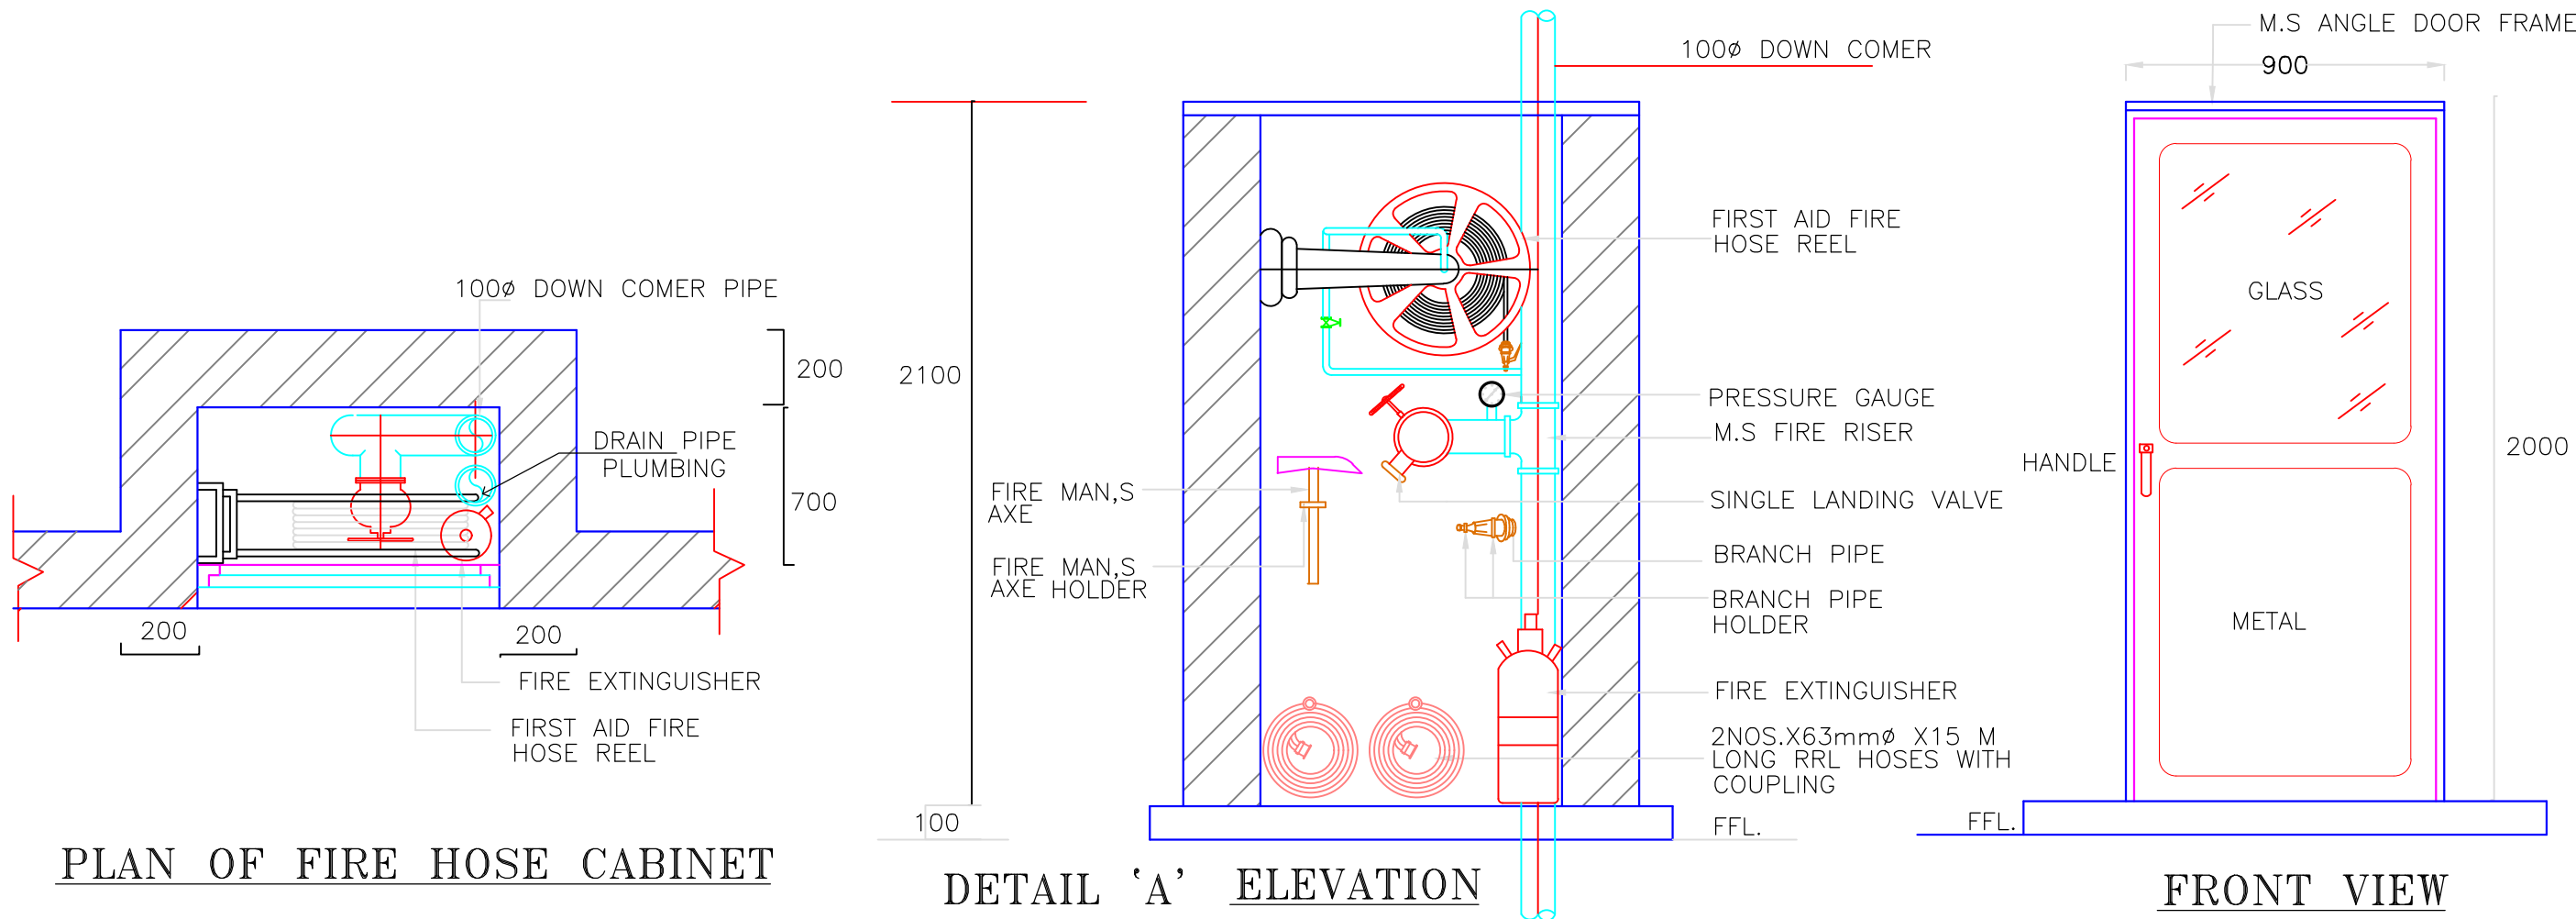

- NOTES:
1. All dimensions are in mm unless noted otherwise.
 2. The dimensions are to be read and not scaled off the drawing.
 3. Any discrepancy in the drawing shall be brought to the notice of the Architects.
 4. This drawing is to be read in conjunction with other relevant drawings & specifications given in the tender document.
 5. Only the latest revision of the drawings shall be considered valid for all purposes.


REVISIONS:		
SL.	DATE	DESCRIPTION

ELECTRICAL CONSULTANT SV Intense Engineering Infrastructure Pvt. Ltd. Velachery, Chennai - 600042
PLUMBING & FIREFIGHTING CONSULTANT Behera & Associates F-623A, Lado Sarai, Behind CNG Station, New Delhi
HVAC CONSULTANT Abid Husain Consultants LG-182, Jeevan Prakash Apartment, 16A, Okhla, New Delhi
STRUCTURAL CONSULTANT Jehovaking Engineering Consultants Pvt. Ltd. 6th Cross Street, Lakshmi Nagar, Porur, Chennai - 600116
PROJECT Infrastructure Development at IIIT Sri City Chittoor
CLIENT Indian Institute of Information Technology Sri City, Chittoor Andhra Pradesh

ARCHITECT ADPL Aadharshila Designs Pvt. Ltd. B - 4/124, L. G. F., Safdarjung Enclave, New Delhi - 110029. Tel: +91 11 26100433 - 6, Fax: +91 11 26177676, E-mail: adpl@adpl.in

COPYRIGHT This drawing is the property of Aadharshila Designs Pvt. Ltd. It shall not be copied, used in any manner and handed over to any person or party without the prior permission of Aadharshila Designs Pvt. Ltd.		
DRAWING TITLE Firefighting Schematic Layout		REV.

DETAILED FIREFIGHTING DRAWINGS (FOR TENDER)

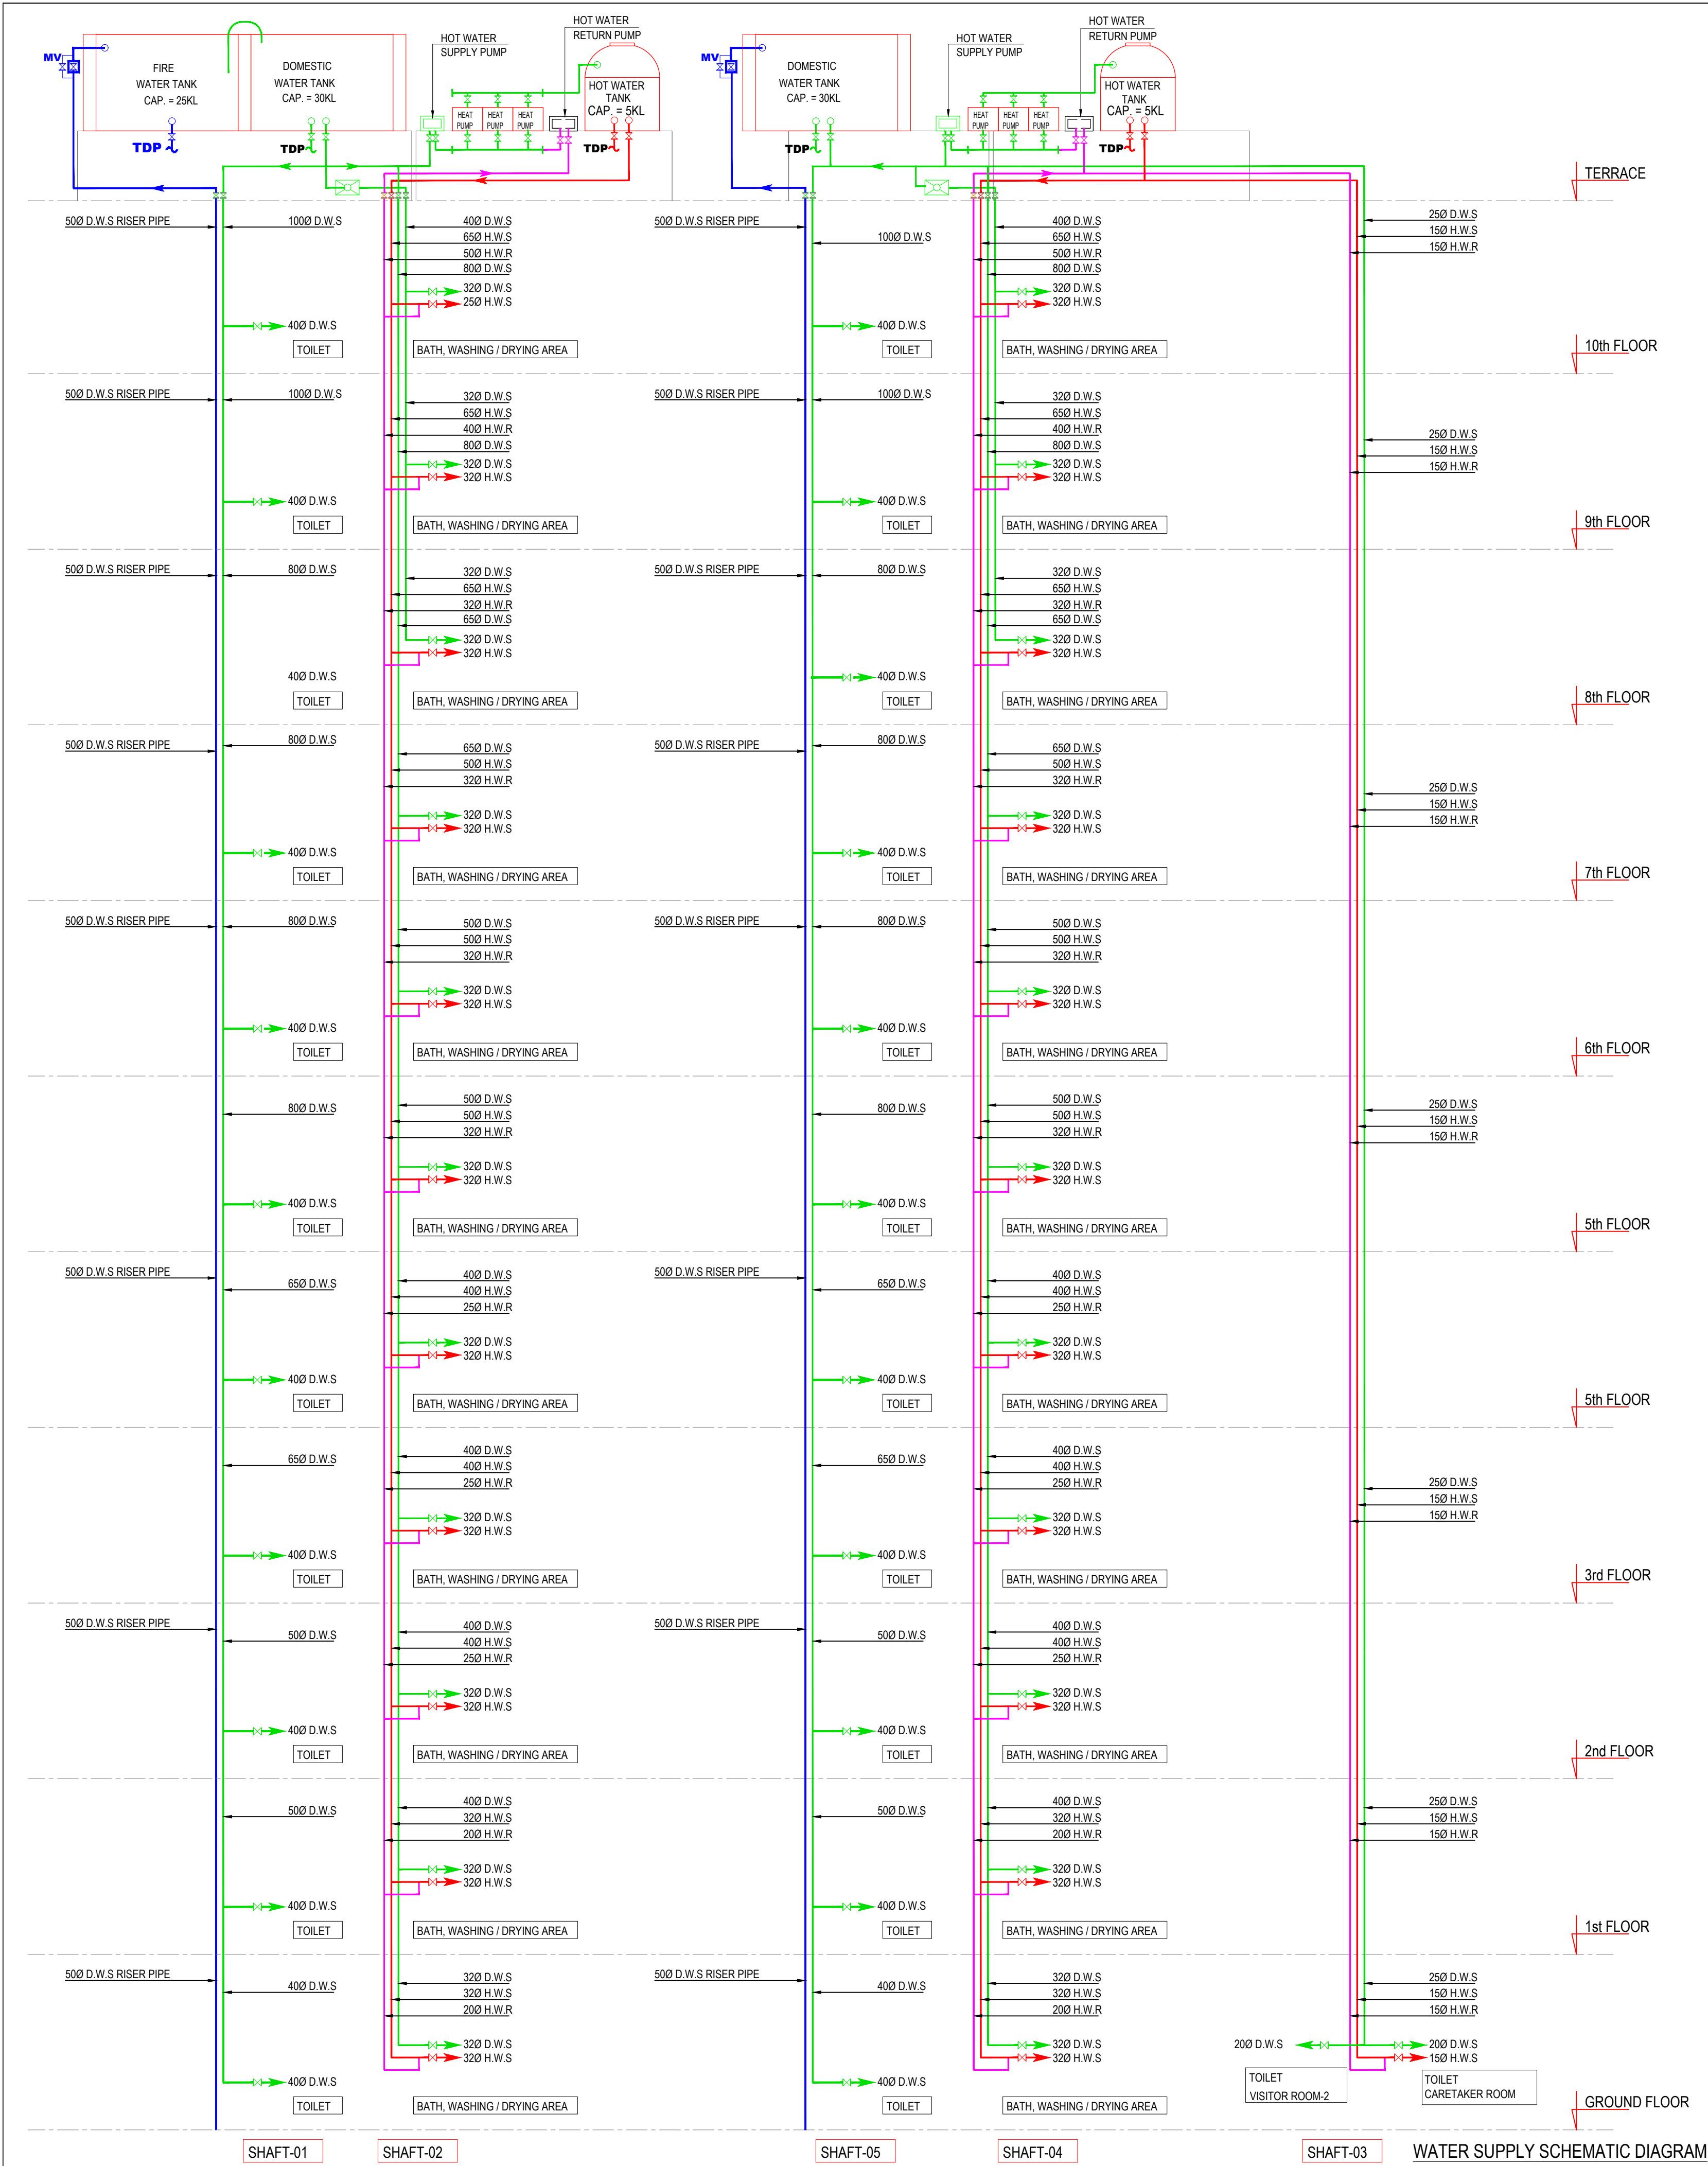

PLUMBING LEGENDS:	
	DOMESTIC WATER SUPPLY PIPE
	HOT WATER SUPPLY PIPE
	HOT WATER RETURN PIPE
	COLD WATER SUPPLY PIPE
	TANK DRAIN PIPE PIPE
	BUTTERFLY VALVE
	NON RETURN VALVE

NOTES:

1.

All dimensions are in mm unless noted otherwise.

2.

The dimensions are to be read and not scaled off the drawing.

3.

Any discrepancy in the drawing shall be brought to the notice of the Architects.

4.

This drawing is to be read in conjunction with other relevant drawings & specifications given in the tender document.

5.

Only the latest revision of the drawings shall be considered valid for all purposes.

REVISIONS:

SL.	DATE	DESCRIPTION

ELECTRICAL CONSULTANT

SV Intense Engineering Infrastructure Pvt. Ltd.

Velachery, Chennai - 600042

PLUMBING & FIREFIGHTING CONSULTANT

Behera & Associates

F-623A, Lado Sarai, Behind CNG Station, New Delhi

HVAC CONSULTANT

Abid Husain Consultants

LG-1&2, Jeevan Prakash Apartment, 16A, Okhla, New Delhi

STRUCTURAL CONSULTANT

Jehovaking Engineering Consultants Pvt. Ltd.

6th Cross Street, Lakshmi Nagar, Porur, Chennai - 600116

PROJECT

Infrastructure Development at IIIT Sri City

Chittoor

CLIENT

Indian Institute of Information Technology

Sri City, Chittoor

Andhra Pradesh

ARCHITECT

ADPL

Aadharshila Designs Pvt. Ltd.

B - 4/124, L. G. F., Safdarjung Enclave, New Delhi - 110029.

Tel: +91 11 26100433 - 6, Fax : +91 11 26177678,

E-mail: adpl@adpl.in

COPYRIGHT

This drawing is the property of Aadharshila Designs Pvt. Ltd. It shall not be copied, used in any manner and handed over to any person or party without the prior permission of Aadharshila Designs Pvt. Ltd.

DRAWING TITLE

Water Supply Schematic Diagram

Boys Hostel 5

DATE

06.02.2025

SCALE

NTS @ A1

REV.


DRAWING NO.

IIITS / BH5 / TD / PL-300

R0

DETAILED PLUMBING DRAWINGS (FOR TENDER)


DETAILED PLUMBING DRAWINGS (FOR TENDER)

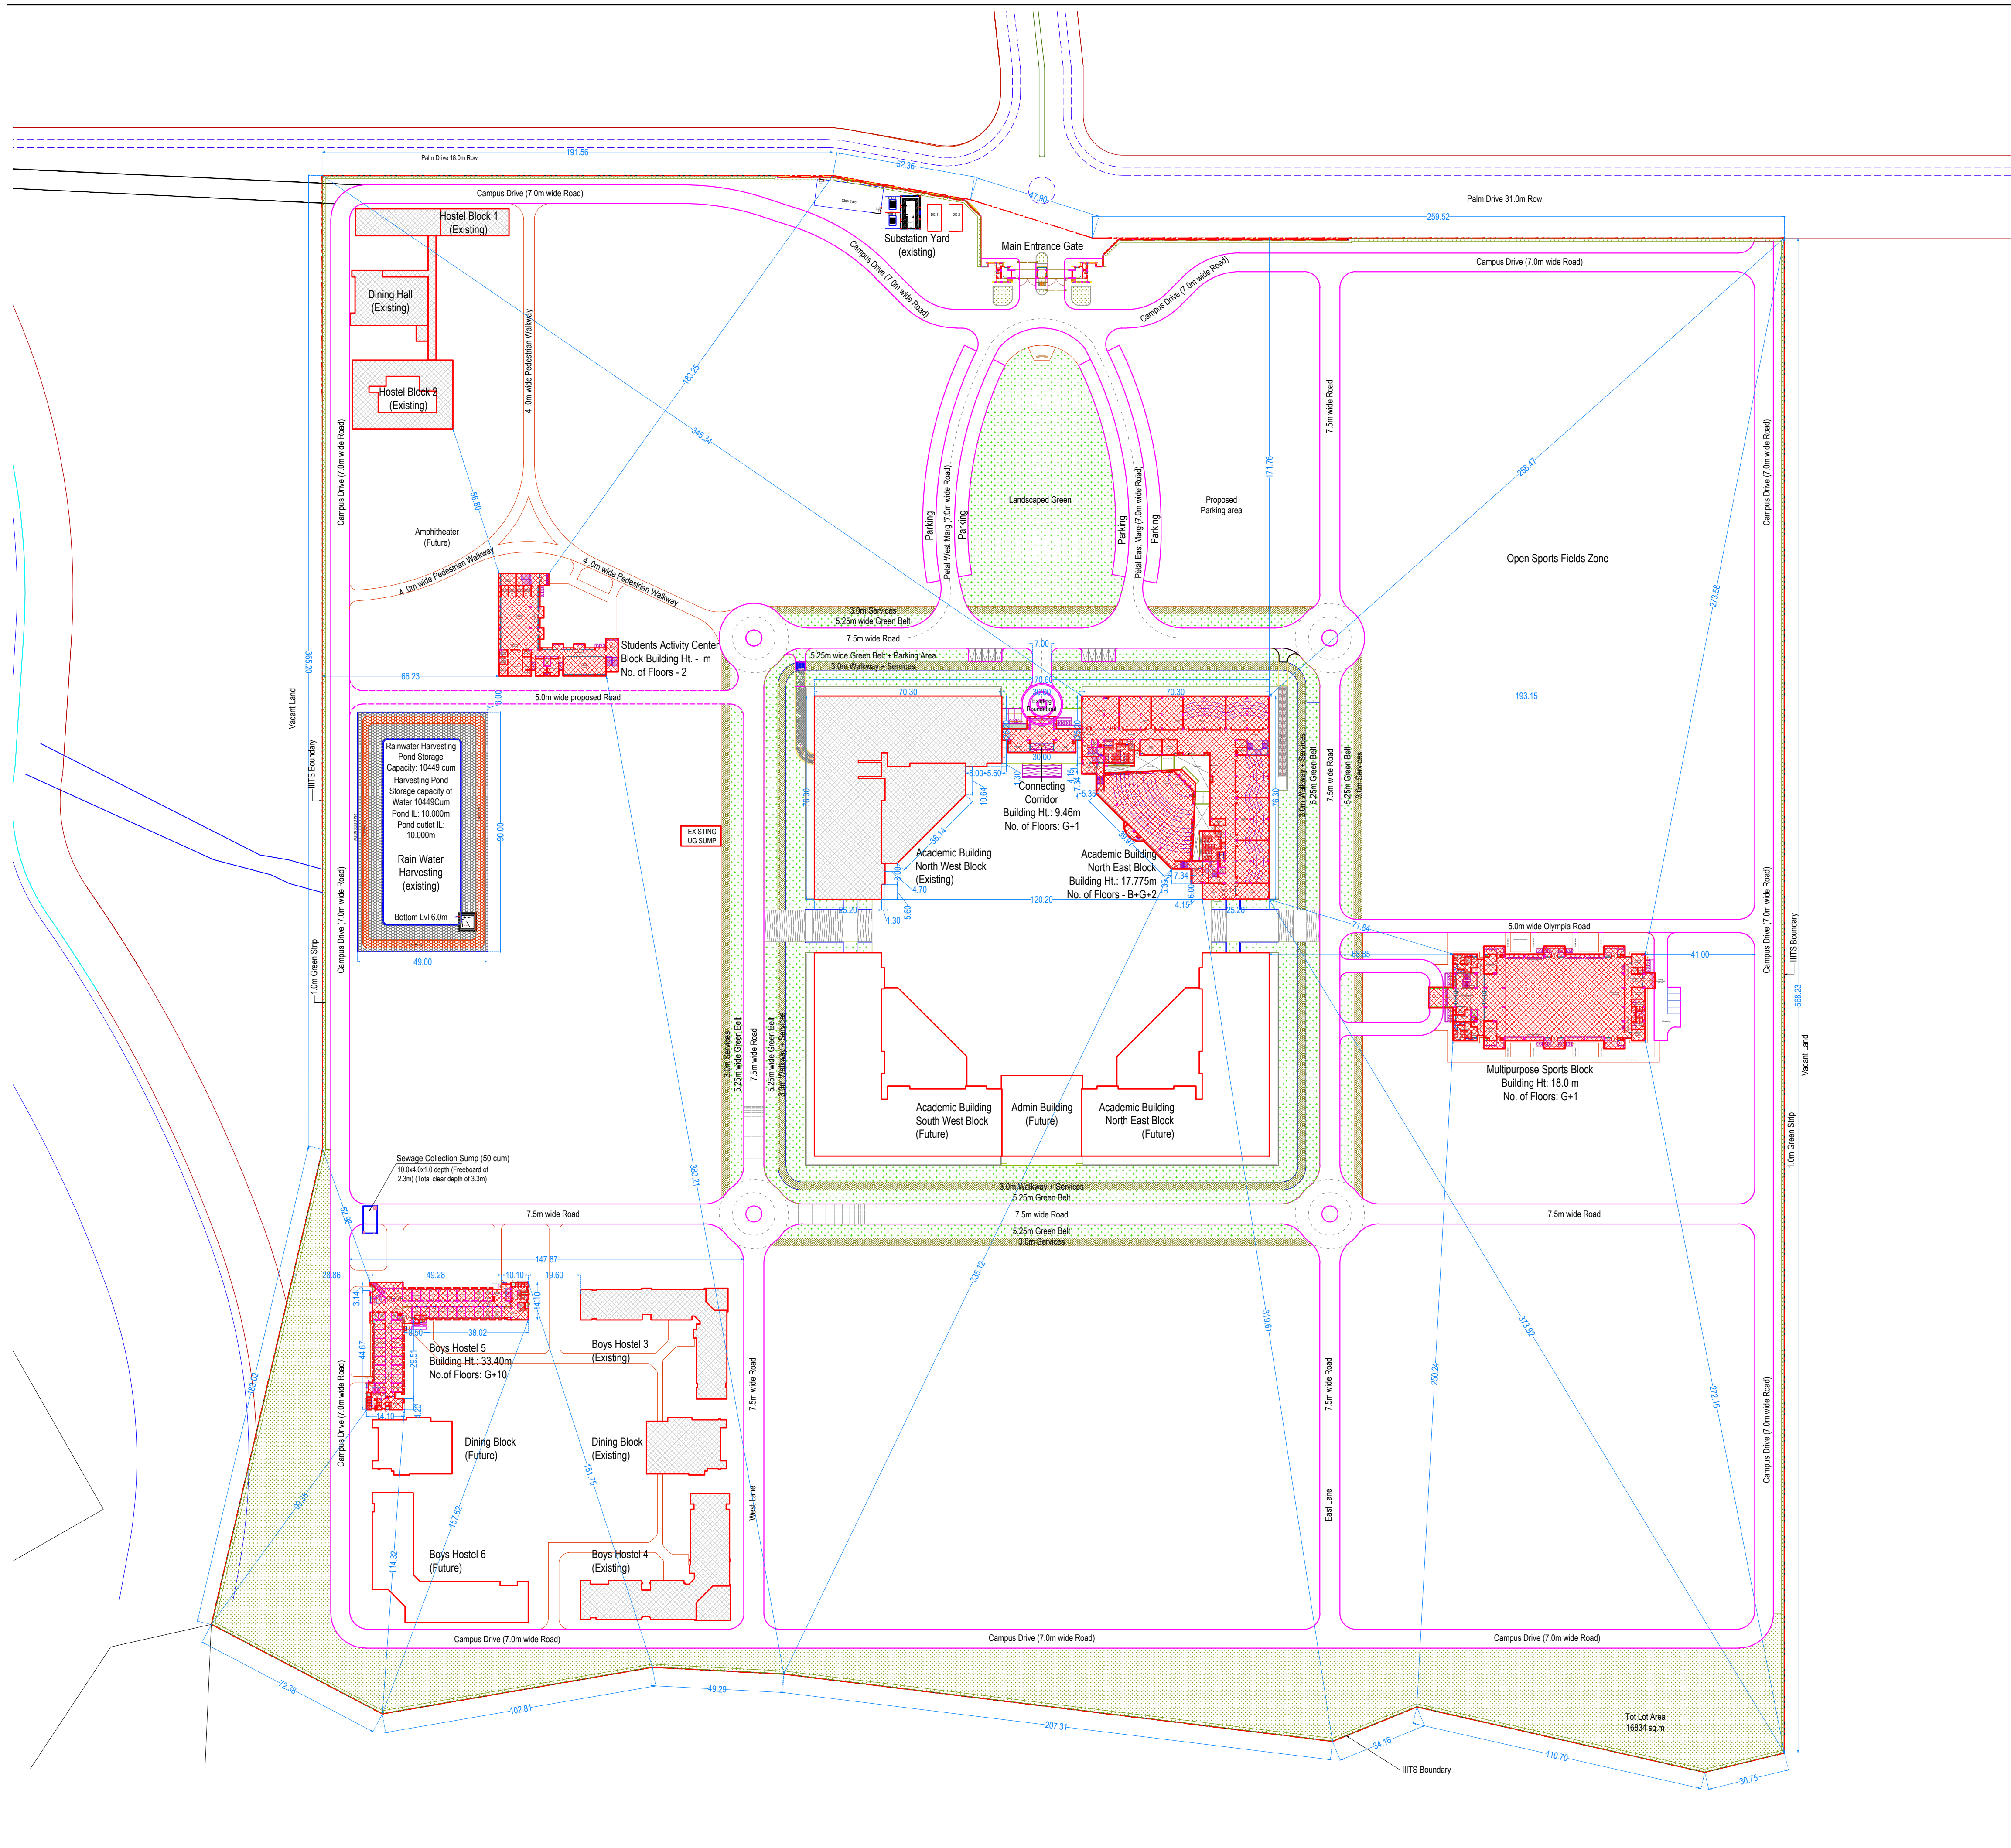

- NOTES:
1. All dimensions are in mm unless noted otherwise.
 2. The dimensions are to be read and not scaled off the drawing.
 3. Any discrepancy in the drawing shall be brought to the notice of the Architects.
 4. This drawing is to be read in conjunction with other relevant drawings & specifications given in the tender document.
 5. Only the latest revision of the drawings shall be considered valid for all purposes.

REVISIONS:		
SL.	DATE	DESCRIPTION
-	-	-
-	-	-
-	-	-
-	-	-
-	-	-
-	-	-
-	-	-
-	-	-

- Existing Buildings
- Proposed Buildings
- Future Buildings
- Landscaped Green
- Site Boundary extents

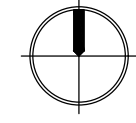ELECTRICAL CONSULTANT SV Intense Engineering Infrastructure Pvt. Ltd. Velachery, Chennai - 600042		
PLUMBING & FIRE-FIGHTING CONSULTANT Behera & Associates F-623A, Lado Sarai, Behind CNG Station, New Delhi		
HVAC CONSULTANT Abid Husain Consultants LG-182, Jeevan Prakash Apartment, 16A, Okhla, New Delhi		
STRUCTURAL CONSULTANT Jehovaking Engineering Consultants Pvt. Ltd. 8th Cross Street, Lakshmi Nagar, Porur, Chennai - 600116		
PROJECT Infrastructure Development at IIIT Sri City Chittoor		
CLIENT Indian Institute of Information Technology Sri City, Chittoor Andhra Pradesh		
ARCHITECT AADPL Aadharshila Designs Pvt. Ltd. B - 4/124, L. G. F., Salfarjung Enclave, New Delhi - 110029. Tel: +91 11 26100433 - 6, Fax: +91 11 26177678, E-mail: adpl@adpl.in		
COPYRIGHT This drawing is the property of Aadharshila Designs Pvt. Ltd. It shall not be copied, used in any manner and handed over to any person or party without the prior permission of Aadharshila Designs Pvt. Ltd.		
DRAWING TITLE Campus Master Plan Existing & Proposed Facilities		 R0
DATE 11.02.2025	SCALE 1:1200 @ A1	
DRAWING NO IIITS / ED / TD / AR-001		